
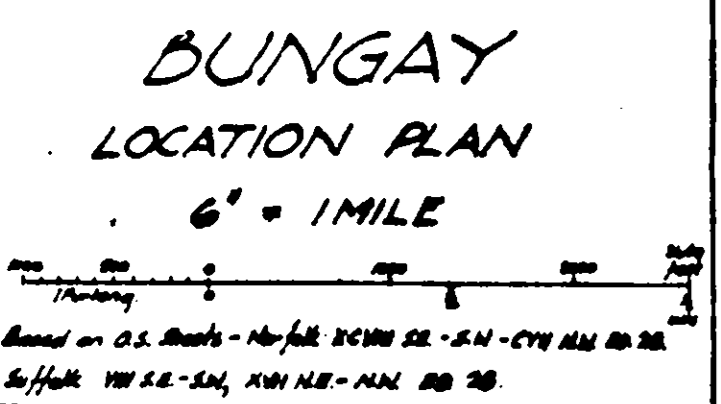


RESTRICTED

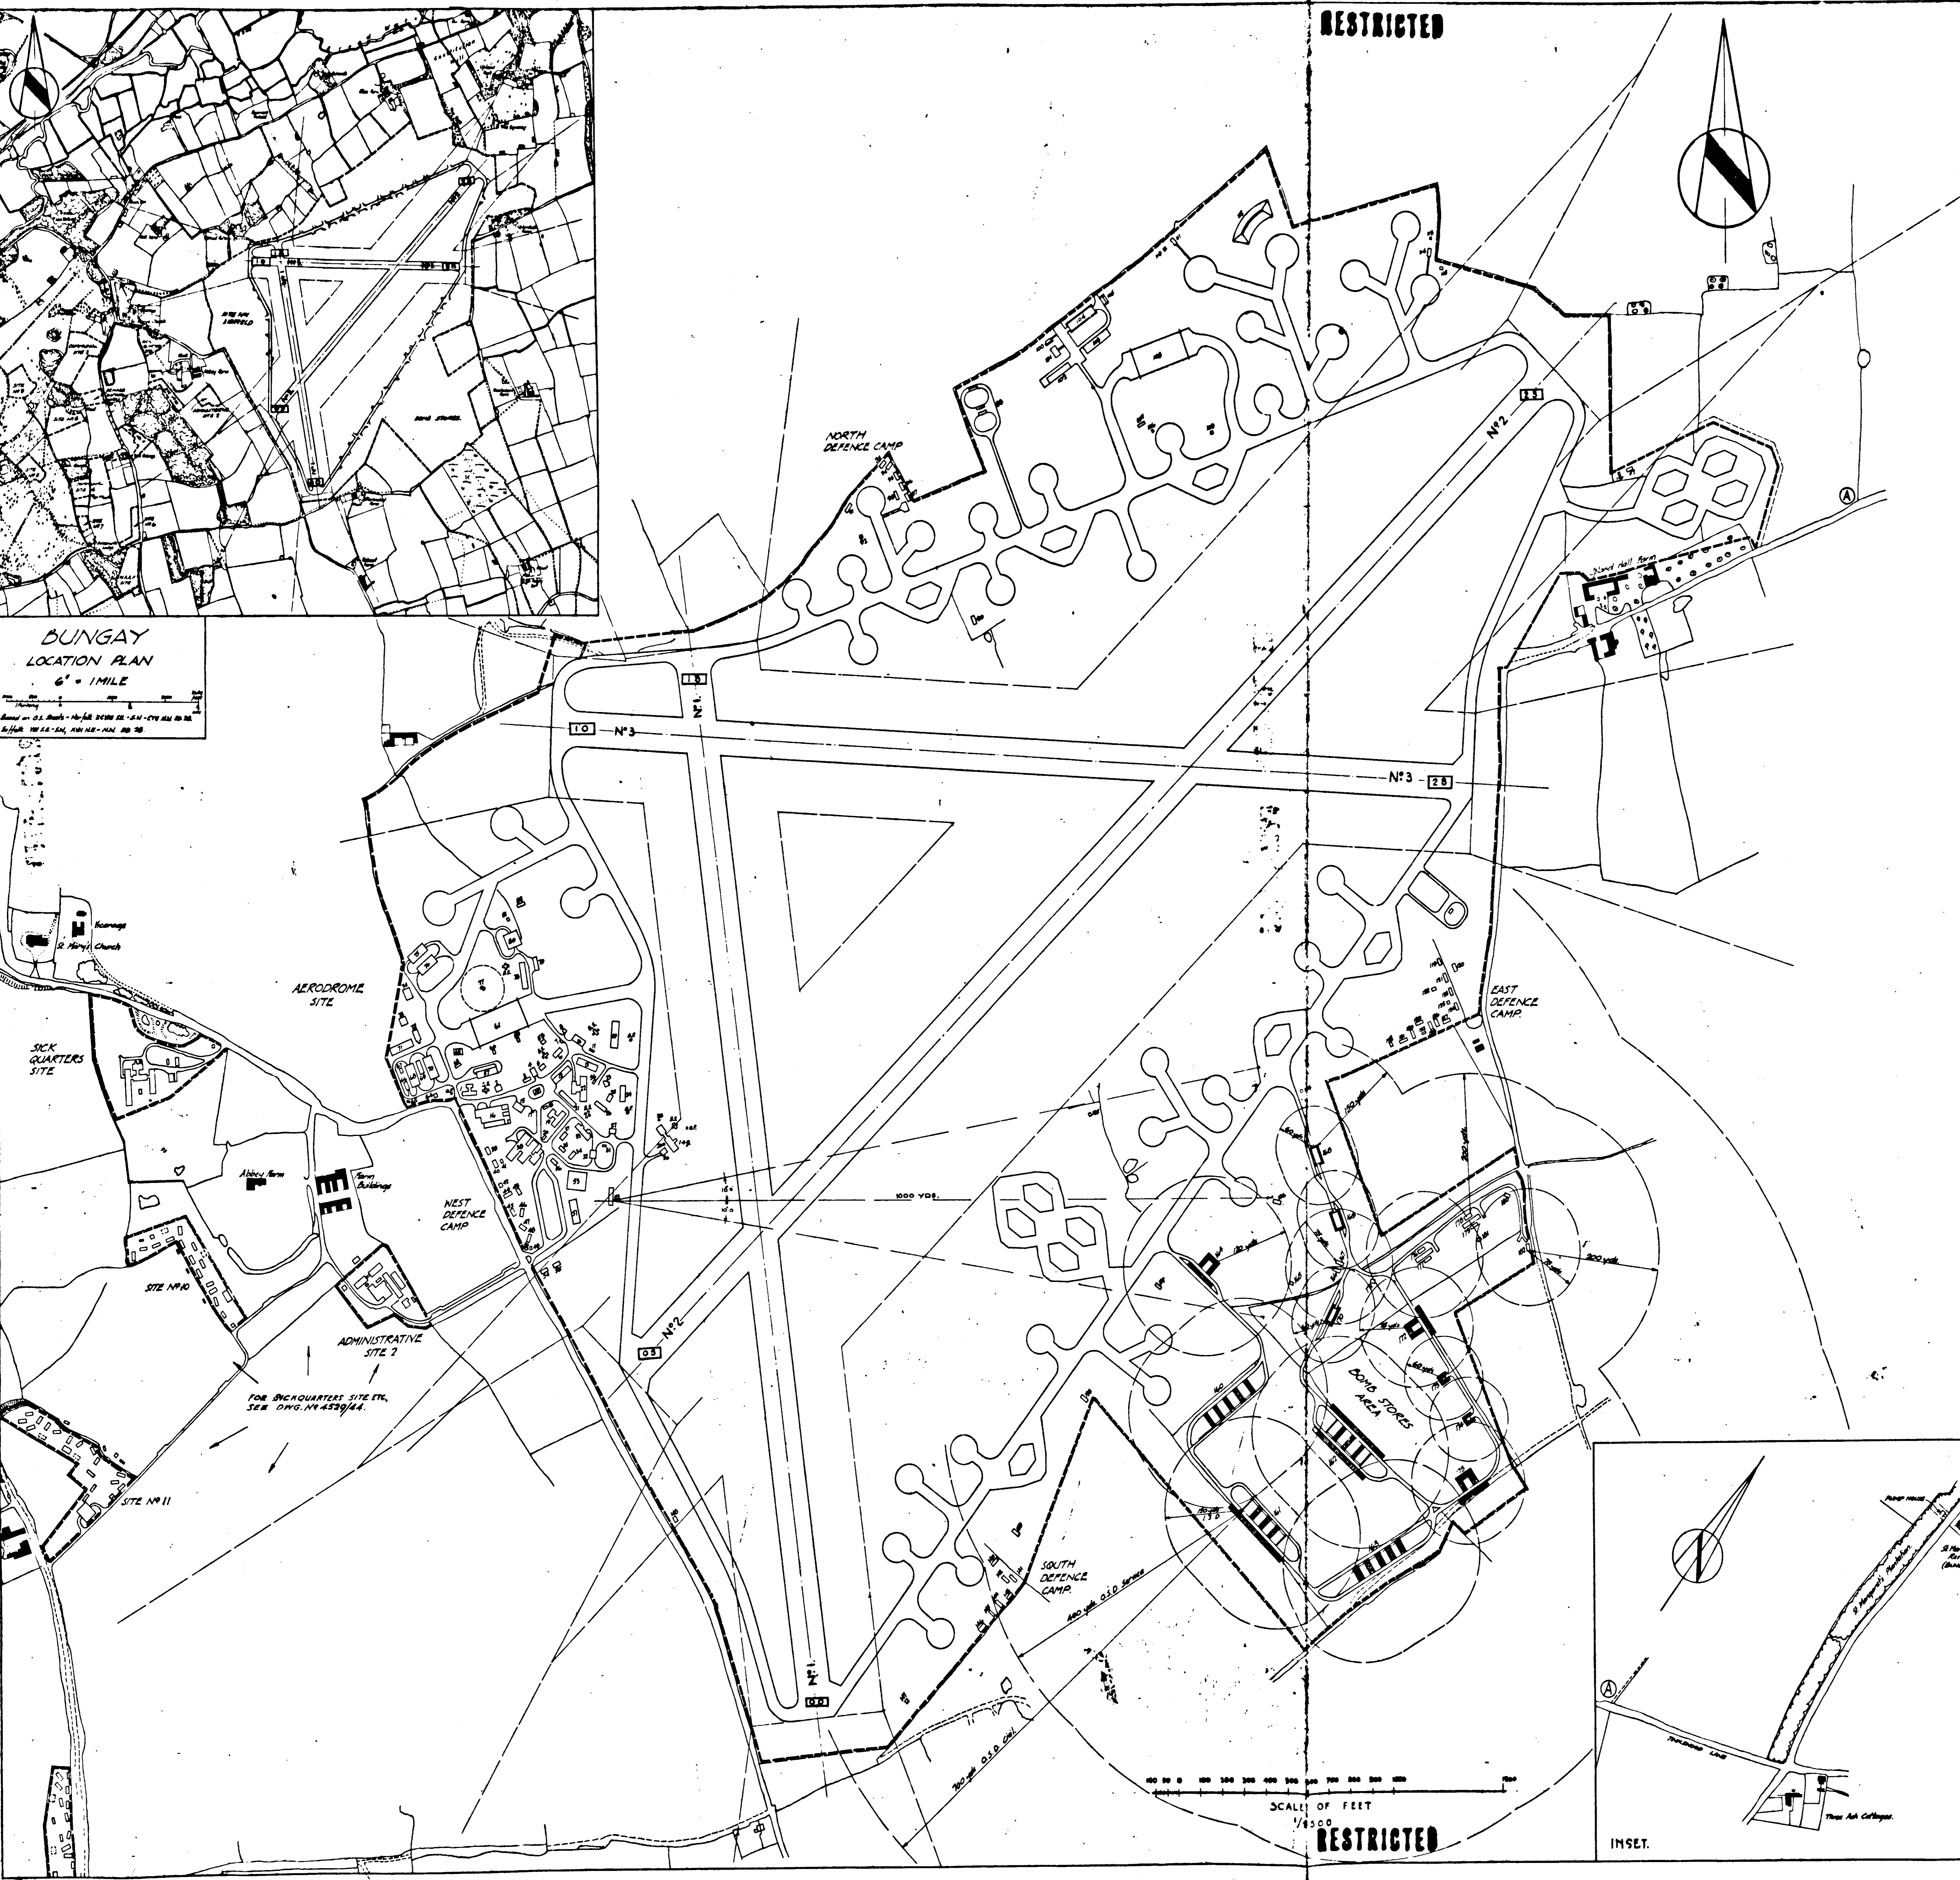

SCHEDULE OF BUILDINGS

ALPHA	BUILDING	CONSTR. TYPE	ENCL. NO.	ALPHA	BUILDING	CONSTR. TYPE	ENCL. NO.
SITE NO. 1 AIRFIELD:							
1	WARD HOUSE & FIRE PARTY	T.B.	5871-41	101	SQUADRON ARMOURIES (2 separate bld)	N	24'
2	SUB-STATION	P.B.	1974-42	102	MAINTENANCE UNIT	N	24'
3	FIRE PARTY HUT	N	36'x16'	103	ARMOURY & MAINTENANCE UNIT	N	24'
4	FIRE TENDER HOUSE	N	24'	104	TECHNICAL LATRINES	T.B.	R.A.P.
5	SUB-STATION	T.B.	7648-40	105	GEN. PURPOSE HUT		
6	GAS DEFENCE CENTRE	P.B.	48-40	106	ARCADE SHED	N	72'
7	PETROL INSTALLATION	M.T.	489-41	107	TRANSFORMER PLINTH		
8	BULK OIL COMPOUND	18'x18'	NIL	108	GEN. PURPOSE HUT		
9	H.D. MECHANICAL PLANT	NAT 287-41	111	GEN. PURPOSE HUT			
10	CREN, REST, LOCKER & DRESSING RMS.	T.B.	3822-41	112	SHOOTING-IN HUT		
11	TECHNICAL LATRINES	T.B.	3846-41	113	LATRINE		
12	ARMOURY	T.B.	3871-41	114	GEN. PURPOSE HUT		
13	MAINTENANCE UNIT & HT	T.B.	3877-41	115	TRANSFORMER PLINTH		
14	M.T. OFFICE	T.B.	1775-41	116	LATRINE		
15	M.T. SHED & OFFICE	T.B. & N	1779-41	117	GEN. PURPOSE HUT		
16	WORK SERVICES HUT & YARD	T.B. & N	7983-41	118	PETROL INSTALLATION (Asphalt)	9100000	15423-40
17	BULK OIL INSTALLATION	T.B.	1770-40	119	SMALL AMHS STORE		
18	BULK PETROL INSTALLATION	M.T.	4728-42	120	FUEL OIL		
19	PHOTOGRAPHIC BLOCK	N	4781-42	121	GEN. PURPOSE HUT		
20	TECHNICAL LATRINES	T.B.	R.A.P.	122	TRANSFORMER PLINTH		
21	OLD CANTEN (KEMOVID)			123	DEFENCE UNIT SQUAD QUARTER	N	4951-41
22	CREN, REST, LOCKER & DRESSING RMS.	T.B.	3891-41	124	" " " " " " " "	T.B.	3866-41
23	A.M. BOMBING TEACHER	P.B.	3501-42	125	" " " " " " " "	N	4861-41
24	STATIC WATER TANK	40'x24'	152103	126	" " " " " " " "		
25	SQUADRON & PLANT OFFICE	T.B.	3892-41	127	" " " " " " " "		
26	SQUADRON & PLANT OFFICE	T.B.	3892-41	128	FLAME POINT STORE		
27	H.F. STORE	T.B.	15417-41	129	LATRINE		
28	SLEEPER STREAMER HAST	S.	12411-41	130	GEN. PURPOSE HUTS		
29	BALLOON HILLMAN HUT	T.B.	NIL	131	A.M. BARRACK HUTS	N	4531-41
30	FIRE TENDER SHED	N	24'	132	A.M. LATRINE	T.B.	5046-41
31	R.U. PYRO. STORE	P.B.	2847-41	133	GEN. PURPOSE HUT		
32	FLOODLIGHT TRAILER & TRACTOR	T.B.	12411-41	134	TRANSFORMER PLINTH		
33	LINK TRAILER BUILDING	T.B.	18'	135	CONTROL TOWER.		
34	PLANT OFFICES	T.B.	4784-42	136	" " " " " " " "		
35	SQUADRON OFFICES	T.B.	4784-42	137	" " " " " " " "		
36	CREN, LOCKER & DRESSING RMS.	N	20'	138	" " " " " " " "		
37	OFFICERS QUARTERS	N	4931-41	139	" " " " " " " "		
38	OFFICERS QUARTERS LATRINE	T.B.	386-41	140	" " " " " " " "		
39	A.M. LATRINE	T.B.	386-41	141	" " " " " " " "		
40	A.M. BARRACK HUTS	N	36'x16'	142	" " " " " " " "		
41	A.M. LATRINE	T.B.	386-41	143	" " " " " " " "		
42	SPEECH BROADCASTING BLD.	T.B.	3485-43	144	" " " " " " " "		
43	REPAIR WORKSHOP	T.B.	7923-42	145	" " " " " " " "		
44	FIRE WORKS CENTRE	S.	4036-42	146	" " " " " " " "		
45	GENERAL PURPOSE HUTS	N	4931-41	147	LATRINE	T.B.	3816-41
46	LATRINE	T.B.	9026-41	148	SMALL BOMB CONTAINER STORE	N	36'x16'
47	ARMOURY MANAGE (B-1) MANAGE UNIT (B-1)	T.B.	1802-42	149	PLUMING POINT BUILDINGS	N	28'x16'
48	GAS CHAMBER	P.B.	12.811-41	150	S.A.A. STORE	N	18'x16'
49	TRANSFORMER PLINTHS			151	INCENDIARY BOMB STORE	PLUMBING	C
50	ARCADE SHED	S	72	152	COMPONENT STORE	N	B
51	STATIC WATER TANK			153	INCENDIARY BOMB STORE	PLUMBING	C
52	TECHNICAL LATRINE	T.B.	R.A.P.	154	INCENDIARY BOMB STORE	N	D
53	BULK OIL INSTALLATION			155	INCENDIARY BOMB STORE	N	24'x16'
54	GAS CYLINDER STORE	N	601-RELOD	156	LATRINE	T.B.	3816-41
55	RUBBER STORE	R.	280-43	157	PYRO STORE	N	18'x16'
56	TECHNICAL LATRINES	T.B.	NA.A.P.	158	" " " " " " " "		
57	MAN STORES	R.	606-45	159	" " " " " " " "		
58	GAS RESP. STORE & WORKSHOP	T.B.	3730-41	160	" " " " " " " "		
59	PARACHUTE STORE	T.B.	1137-41	161	" " " " " " " "		
60	EMERGENCY SHED	T.B.	3803-43	162	" " " " " " " "		
61	MAINTENANCE STAFF BLOCK	N	24'	163	" " " " " " " "		
62	MAN WORKSHOPS	R.	627-43	164	" " " " " " " "		
63	R.U. PYRO STORE	P.B.	5488-42	165	" " " " " " " "		
64	SQUADRON ARMOURIES	S	24'	166	" " " " " " " "		
65	LUBRICANT & INFLAMMABLE STORE	T.B.	3821-41	167	" " " " " " " "		
66	FUEL OIL COMPOUND	63'x54'	3821-41	168	" " " " " " " "		
67	LATRINE	T.B.	3816-41	169	" " " " " " " "		
68	GENERAL PURPOSE HUT	N	4.931-41	170	" " " " " " " "		
69	GENERAL PURPOSE HUT	N	4.931-41	171	" " " " " " " "		
70	TRANSFORMER PLINTH	P.B.	NIL	172	" " " " " " " "		
71	A.M. BARRACK HUTS	N	6'x16'	173	" " " " " " " "		
72	A.M. LATRINE	T.B.	386-41	174	" " " " " " " "		
73	BULK PETROL INSTALLATION	T.B.	9046-41	175	" " " " " " " "		
74	TECHNICAL LATRINES	T.B.	9026-41	176	" " " " " " " "		
75	MAINTENANCE STAFF BLOCK	N	24'	177	" " " " " " " "		

BOMB STORES

ALPHA	BUILDING	CONSTR. TYPE	ENCL. NO.	ALPHA	BUILDING	CONSTR. TYPE	ENCL. NO.
1004	CONCRETE BOMB STORE	T.B.	7812-43	1005	CONCRETE BOMB STORE	T.B.	1780-42
1006	MIXED & SPARE BOMB STORE	D'	3816-41	1007	LATRINE	T.B.	3816-41
1008	SMALL BOMB CONTAINER STORE	N	36'x16'	1009	PLUMING POINT BUILDINGS	N	28'x16'
1010	S.A.A. STORE	N	18'x16'	1011	INCENDIARY BOMB STORE	PLUMBING	C
1012	COMPONENT STORE	N	B	1013	INCENDIARY BOMB STORE	N	D
1014	INCENDIARY BOMB STORE	N	24'x16'	1015	LATRINE	T.B.	3816-41
1016	PYRO STORE	N	18'x16'	1017	" " " " " " " "		

ADMINISTRATIVE SITE.
SEE DWG. NO. 4529/4A.

CONSTRUCTION ABBREVIATIONS

TEMPORARY BRICK SLABS INDICATED THIS	T.B.
CONCRETE	T.C.
PERMANENT BRICK	P.B.
CONCRETE	P.C.
STEEL SLABS	S.
ROUPEY HUTTING	R.
TIMBER	T.
PLASTERBOARD HUTTING	P.
CORRUGATED IRON	C.I.
M.C.M.	M.
ALUMINIUM	A.
WIRE MESH	W.
BLAST SHELTERS	B.S.
AR. ROAD	A.R.
CYCLE STANDS	C.S.
GUN POSTS	G.P.
SILT TRENCHES	S.T.

Based on Works Area 7 Dwg. W.A.T. 1858 to 1853/4A
BUNGAY
RECORD SITE PLAN
SITE NO. 1 [AIRFIELD SITE]
FOR DISPersed SITES SEE DWG. NO. 4529/4A.

NOTE

THIS DRAWING IS THE PROPERTY OF THE DEFENCE RESEARCH AND DEVELOPMENT BOARD AND IS NOT TO BE REPRODUCED OR TRANSMITTED IN ANY FORM OR BY ANY MEANS, ELECTRONIC OR MECHANICAL, INCLUDING PHOTOCOPYING, RECORDING, OR BY ANY INFORMATION STORAGE AND RETRIEVAL SYSTEM, WITHOUT THE WRITTEN PERMISSION OF THE BOARD.

SCALE: 1/2500

SECRET NO. **4528**

FOR NO. **1**

FOR D.B.M. **14**

NOV. 1944

BY MINISTRY

RESTRICTED